 


PANEL DESIG: AE PANELBOARD				VOLTAGE: 480Y/277V					
LOCATION: INVERTER BUILDING									
MOUNTING: SURFACE									
NO. OF CKTS: 48				MAIN SIZE: 600A					
ALL PHASES TO BE BALANCED WITHIN 3% USING ACTUAL CONNECTED LOAD									
LOAD DESCRIPTION	(VA)	WIRE SIZE	CB/P	CKT. NUM.	CKT. NUM.	CB/P	WIRE SIZE	(VA)	LOAD DESCRIPTION
INVERTER 2			25/3	01 *-----	02	25/3			INVERTER 3
	-	-		03 ----*	04		-	-	
	-	-		05 -----*	06		-	-	
INVERTER 1	-	-	30/3	07 *-----	08	30/3	-	-	INVERTER 11
	-	-		09 ----*	10		-	-	
	-	-		11 -----*	12		-	-	
INVERTER 4	-	-	30/3	13 *-----	14	30/3	-	-	INVERTER 10
	-	-		15 ----*	16		-	-	
	-	-		17 -----*	18		-	-	
INVERTER 5	-	-	30/3	19 *-----	20	30/3	-	-	INVERTER 13
	-	-		21 ----*	22		-	-	
	-	-		23 -----*	24		-	-	
INVERTER 16	-	-	30/3	25 *-----	26	30/3	-	-	INVERTER 14
	-	-		27 ----*	28		-	-	
	-	-		29 -----*	30		-	-	
INVERTER 8	-	-	30/3	31 *-----	32	30/3	-	-	INVERTER 15
	-	-		33 ----*	34		-	-	
	-	-		35 -----*	36		-	-	
INVERTER 9	-	-	30/3	37 *-----	38	30/3	-	-	INVERTER 7
	-	-		39 ----*	40		-	-	
	-	-		41 -----*	42		-	-	
INVERTER 12	-	-	30/3	43 *-----	44	50/3	-	-	INVERTER 6
	-	-		45 ----*	46		-	-	
	-	-		47 -----*	48		-	-	
N.E.C. Connected Load Summary				Breaker Options (if used)					
Lighting:	2.6 KVA	Motors:	144.8 KVA	AS - Powerlink "AS" breaker		QO - Standard "QOB" Bolt-On Bkr.			
Recept:	6.0 KVA	Heating:	2.4 KVA	LO - Lock-On Device		HR-HACR Rated Circuit Breaker			
Kitch Eq:	0.4 KVA	Total:	155.8 KVA	187.3 Amps	GF - GND Fault CKT Interrupter				

SCALE: N.T.S.



1	8 TO 2X4 STRINGS/CHANNEL
2	12 TO 4X3 STRINGS/CHANNEL
3A,B	8 TO 2X4 STRINGS/CHANNEL
3C	10 TO 2X5 STRINGS/CHANNEL
2A-F	8 TO 2X4 STRINGS/CHANNEL
5A-C	8 TO 2X4 STRINGS/CHANNEL
5D	9 TO 1X4 + 1X5 STRINGS/CHANNEL



SCALE: N.T.S.

Drawing Description	PICKERING ENERGY SOLUTIONS CHARLES TOWN, WEST VIRGINIA APUS SOLAR REPOWERING PROJECT ELECTRICAL POWER PLAN
---------------------	---

Project:	219001
Designed By:	CL
Drawn By:	JGH
Checked By:	
Scale:	
Plot Date:	06/24/1
Revision:	
Drawing Number:	E601

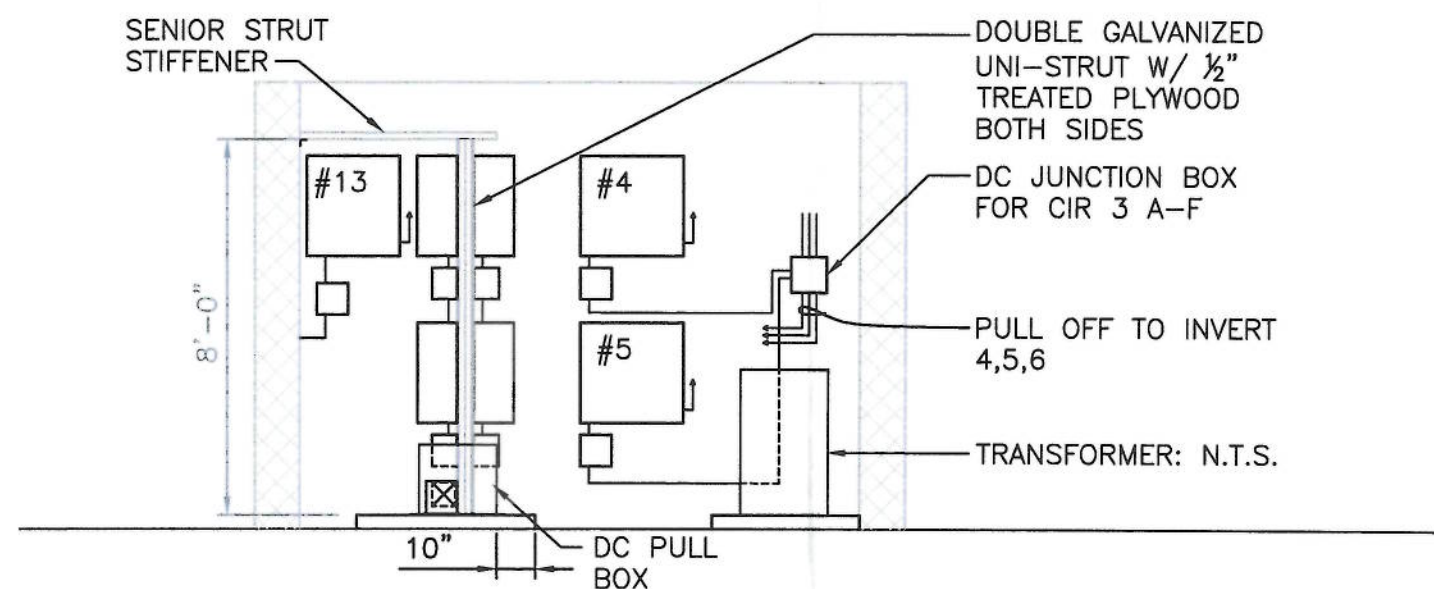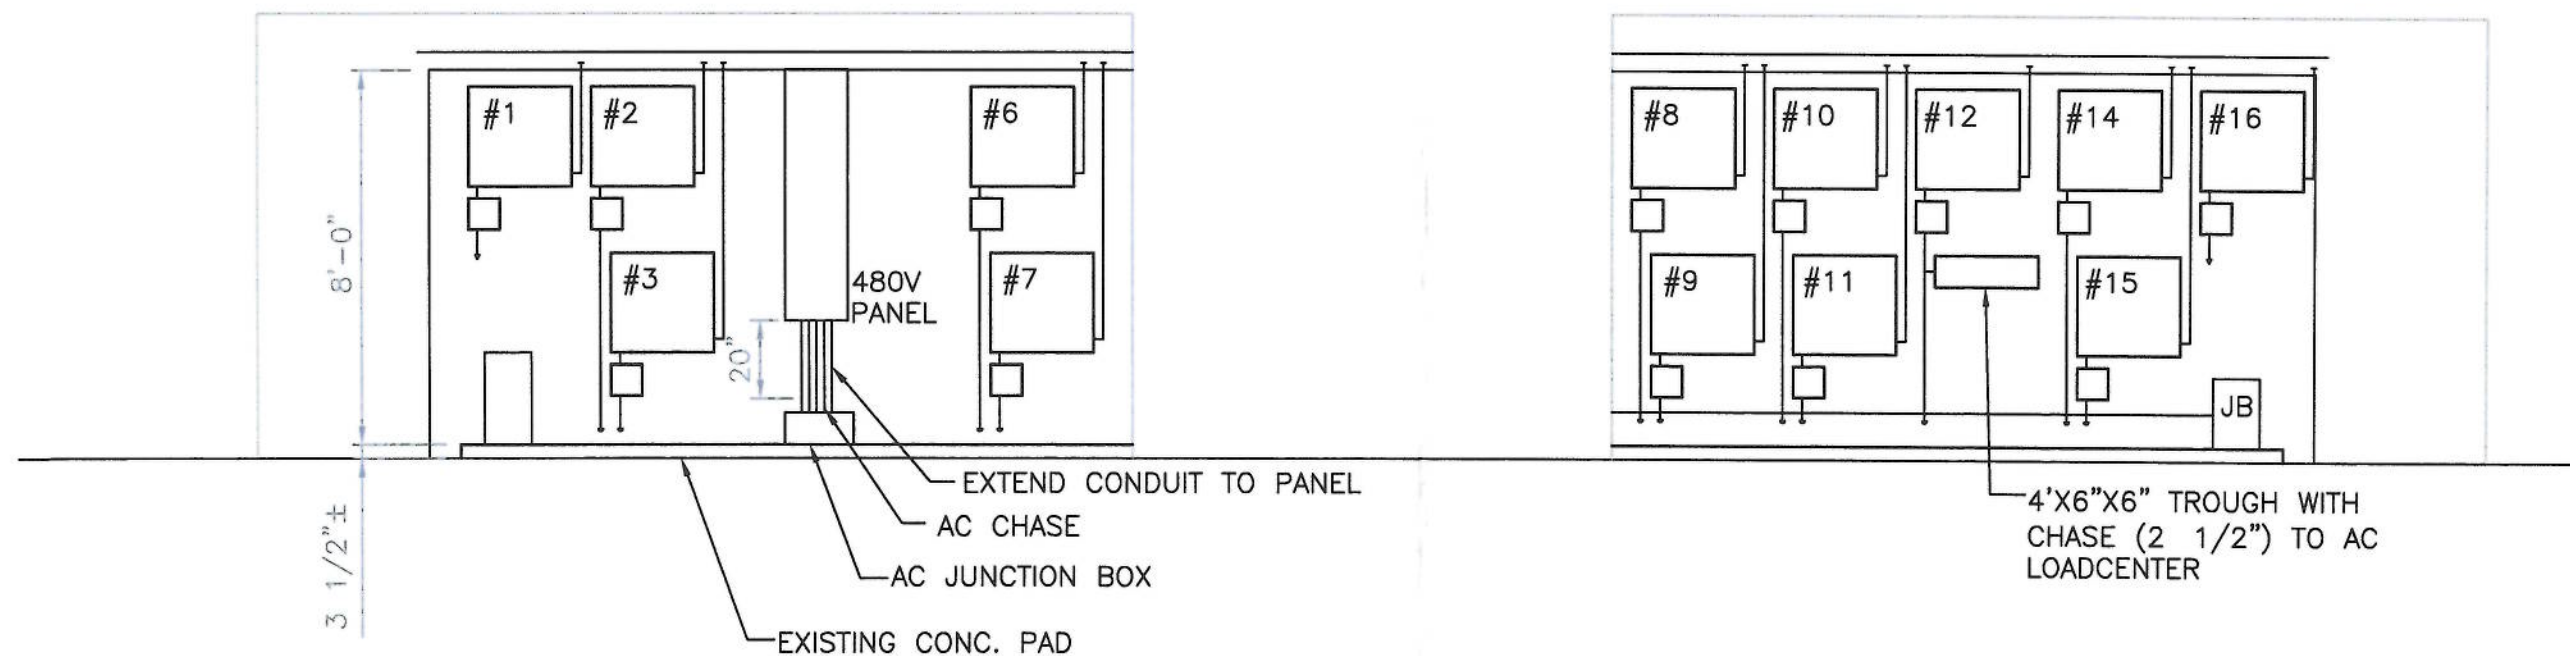




PICKERING ASSOCIATES
 Architects • Engineers • Surveyors
 11283 Emerson Avenue
 Parkersburg, West Virginia 26104
 Phone: (304) 464-5305
 Fax: (304) 464-4428

Rev.	Description	By	Date
1	ISSUED FOR AS-BUILT	JB	06/24/19

Drawing Description

PICKERING ENERGY SOLUTIONS
 CHARLES TOWN, WEST VIRGINIA
 APUS SOLAR REPOWERING PROJECT
 ELEVATIONS AND SECTIONS

Project:	2190012
Designed By:	CLP
Drawn By:	JGH
Checked By:	-
Scale:	-
Plot Date:	06/24/19
Revision:	1
Drawing Number:	A301

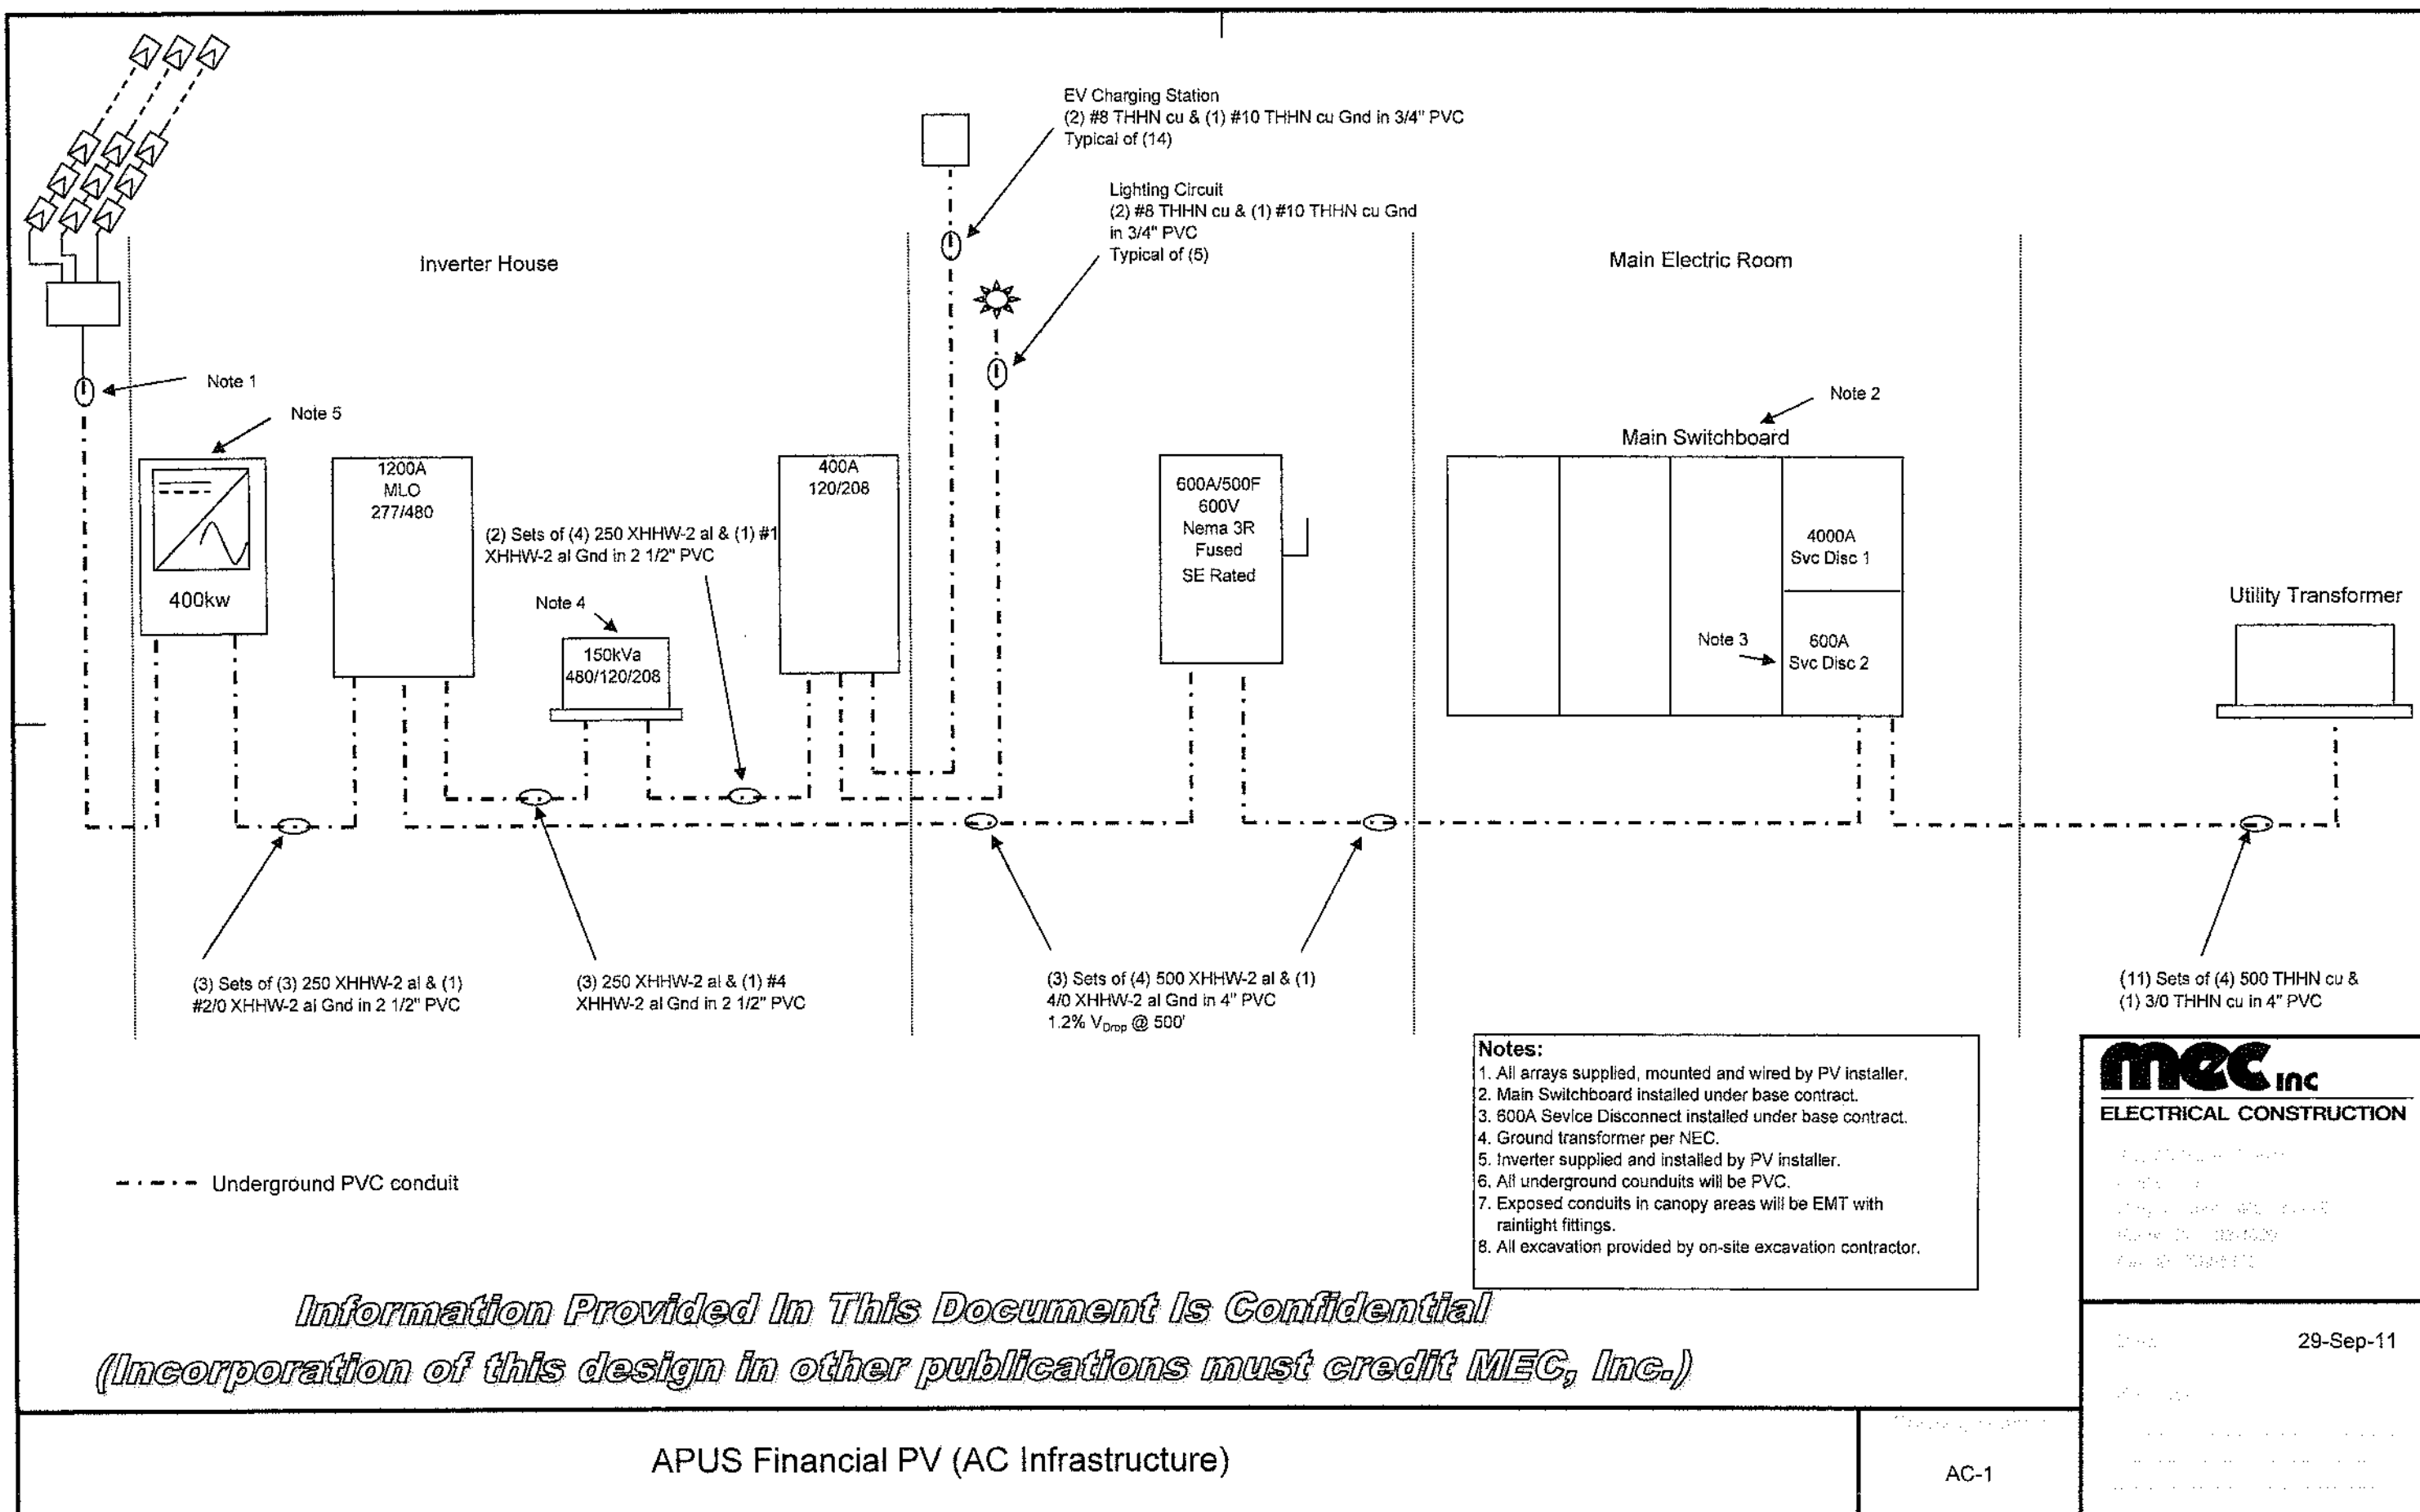

Panel Name: JHLV (NEMA 3R)			Panel Amperage: 400		
Voltage & Phase: 120/208Y—3Ø			Panel A.I.C. Rating: 10kAIC		
Mounting: Surface			Other: MCB / Bottom Fed		
Description	Brk	Phase	Brk	Description	
Car Charger 1	40	1 A 2	40	Car Charger 8	
Car Charger 1	40	3 B 4	40	Car Charger 8	
Car Charger 2	40	5 C 6	40	Car Charger 9	
Car Charger 2	40	7 A 8	40	Car Charger 9	
Car Charger 3	40	9 B 10	40	Car Charger 10	
Car Charger 3	40	11 C 12	40	Car Charger 10	
Car Charger 4	40	13 A 14	40	Car Charger 11	
Car Charger 4	40	15 B 16	40	Car Charger 11	
Car Charger 5	40	17 C 18	40	Car Charger 12	
Car Charger 5	40	19 A 20	40	Car Charger 12	
Car Charger 6	40	21 B 22	40	Car Charger 13	
Car Charger 6	40	23 C 24	40	Car Charger 13	
Car Charger 7	40	25 A 26	40	Car Charger 14	
Car Charger 7	40	27 B 28	40	Car Charger 14	
Lighting Ckt 1	20	29 C 30	20	Prepared Space	
Lighting Ckt 2	20	31 A 32	20	Prepared Space	
Lighting Ckt 3	20	33 B 34	20	Prepared Space	
Lighting Ckt 4	20	35 C 36	20	Prepared Space	
Lighting Ckt 5	20	37 A 38	20	Prepared Space	
Receptacle Ckt	20	39 B 40	20	Prepared Space	
Space		41 C 42		Space	

Panel Name: JHHV (NEMA 3R)			Panel Amperage: 1200				
Voltage & Phase: 277/480Y—3Ø			Panel A.I.C. Rating: 30kAIC				
Mounting: Surface			Other: MLO / Bottom Fed				
Description		Brk	Phase		Brk	Description	
Inverter Feed		600	1	A	2	30	TVSS
Inverter Feed		600	3	B	4	30	TVSS
Inverter Feed		600	5	C	6	30	TVSS
XFMR 150Kva		200	7	A	8		
XFMR 150Kva		200	9	B	10		
XFMR 150Kva		200	11	C	12		

High Voltage panelboard to be Square D I-Line
Low Voltage panelboard to be Square D NQOD
Utility Disconnect will be Square D 600A, 600V, 3Ø, Service Entrance Rated, Fused, NEMA 3R
TVSS will be Square D 120KA 480V

Information Provided In This Document Is Confidential
(Incorporation of this design in other publications must credit MEC, Inc.)



ARRAY SPECIFICATIONS:

CANOPY 1: 8-STRINGS, (104) 240W MODULES, 25.0 KW
CANOPY 2: 12-STRINGS (156) 240W MODULES, 37.4KW
CANOPY 3: 26-STRINGS (338) 240W MODULES, 81.1KW
CANOPY 4: 48 STRINGS, (624) 250W MODULES, 156.0KW
CANOPY 5: 33 STRINGS, (429) 250W MODULES, 107.3KW
TOTAL: 127 STRINGS, (1651) MODULES, 406.8KW

NOTE:
THE RACKING SYSTEM SHOULD
EXTEND A MINIMUM OF 3" BEYOND
THE PANELS.

A STRING, MODULE & COMBINER BOX LAYOUT
0.1 SCALE: 1"=150'



MOUNTAIN VIEW SOLAR & WIND
11500 Valley Rd. Berkley Springs, WV 25411
ph. 304.258.4733 postmaster@mtvsolar.com

APUS Finance Center Buchanan & 2nd
St. Charlestown, WV 25313


REVISIONS				STRING, MODULE & COMBINER BOX LAYOUT			
No.	By	Date	DESCRIPTION	SCALE	DATE	DRAWN BY	PROJECT NO.
1.	TEY/CH	10/24/2011	ELECTRICAL LAYOUT	1"=150'	DATE	TEY/CH	APUS
2.	TEY/CH	12/10/2011	ECP GRND				
3.	TEY/CH	01/12/2013	FINAL				
4.							

D-SIZE BORDER: 36" x 24"

THE DRAWINGS AND DATA IN THIS DOCUMENT, AND THE INTELLECTUAL PROPERTY AND CONFIDENTIAL INFORMATION IT CONTAINS ARE THE PROPERTY OF MOUNTAIN VIEW SOLAR AND WIND. ANY PARTY ACCEPTING THIS DOCUMENT DOES SO IN CONFIDENCE AND AGREES THAT IT SHALL NOT BE DUPLICATED, IN WHOLE OR IN PART, NOR DISCLOSED TO OTHERS WITHOUT THE WRITTEN CONSENT.

AS-BUILT

SHEET NO. A1.01

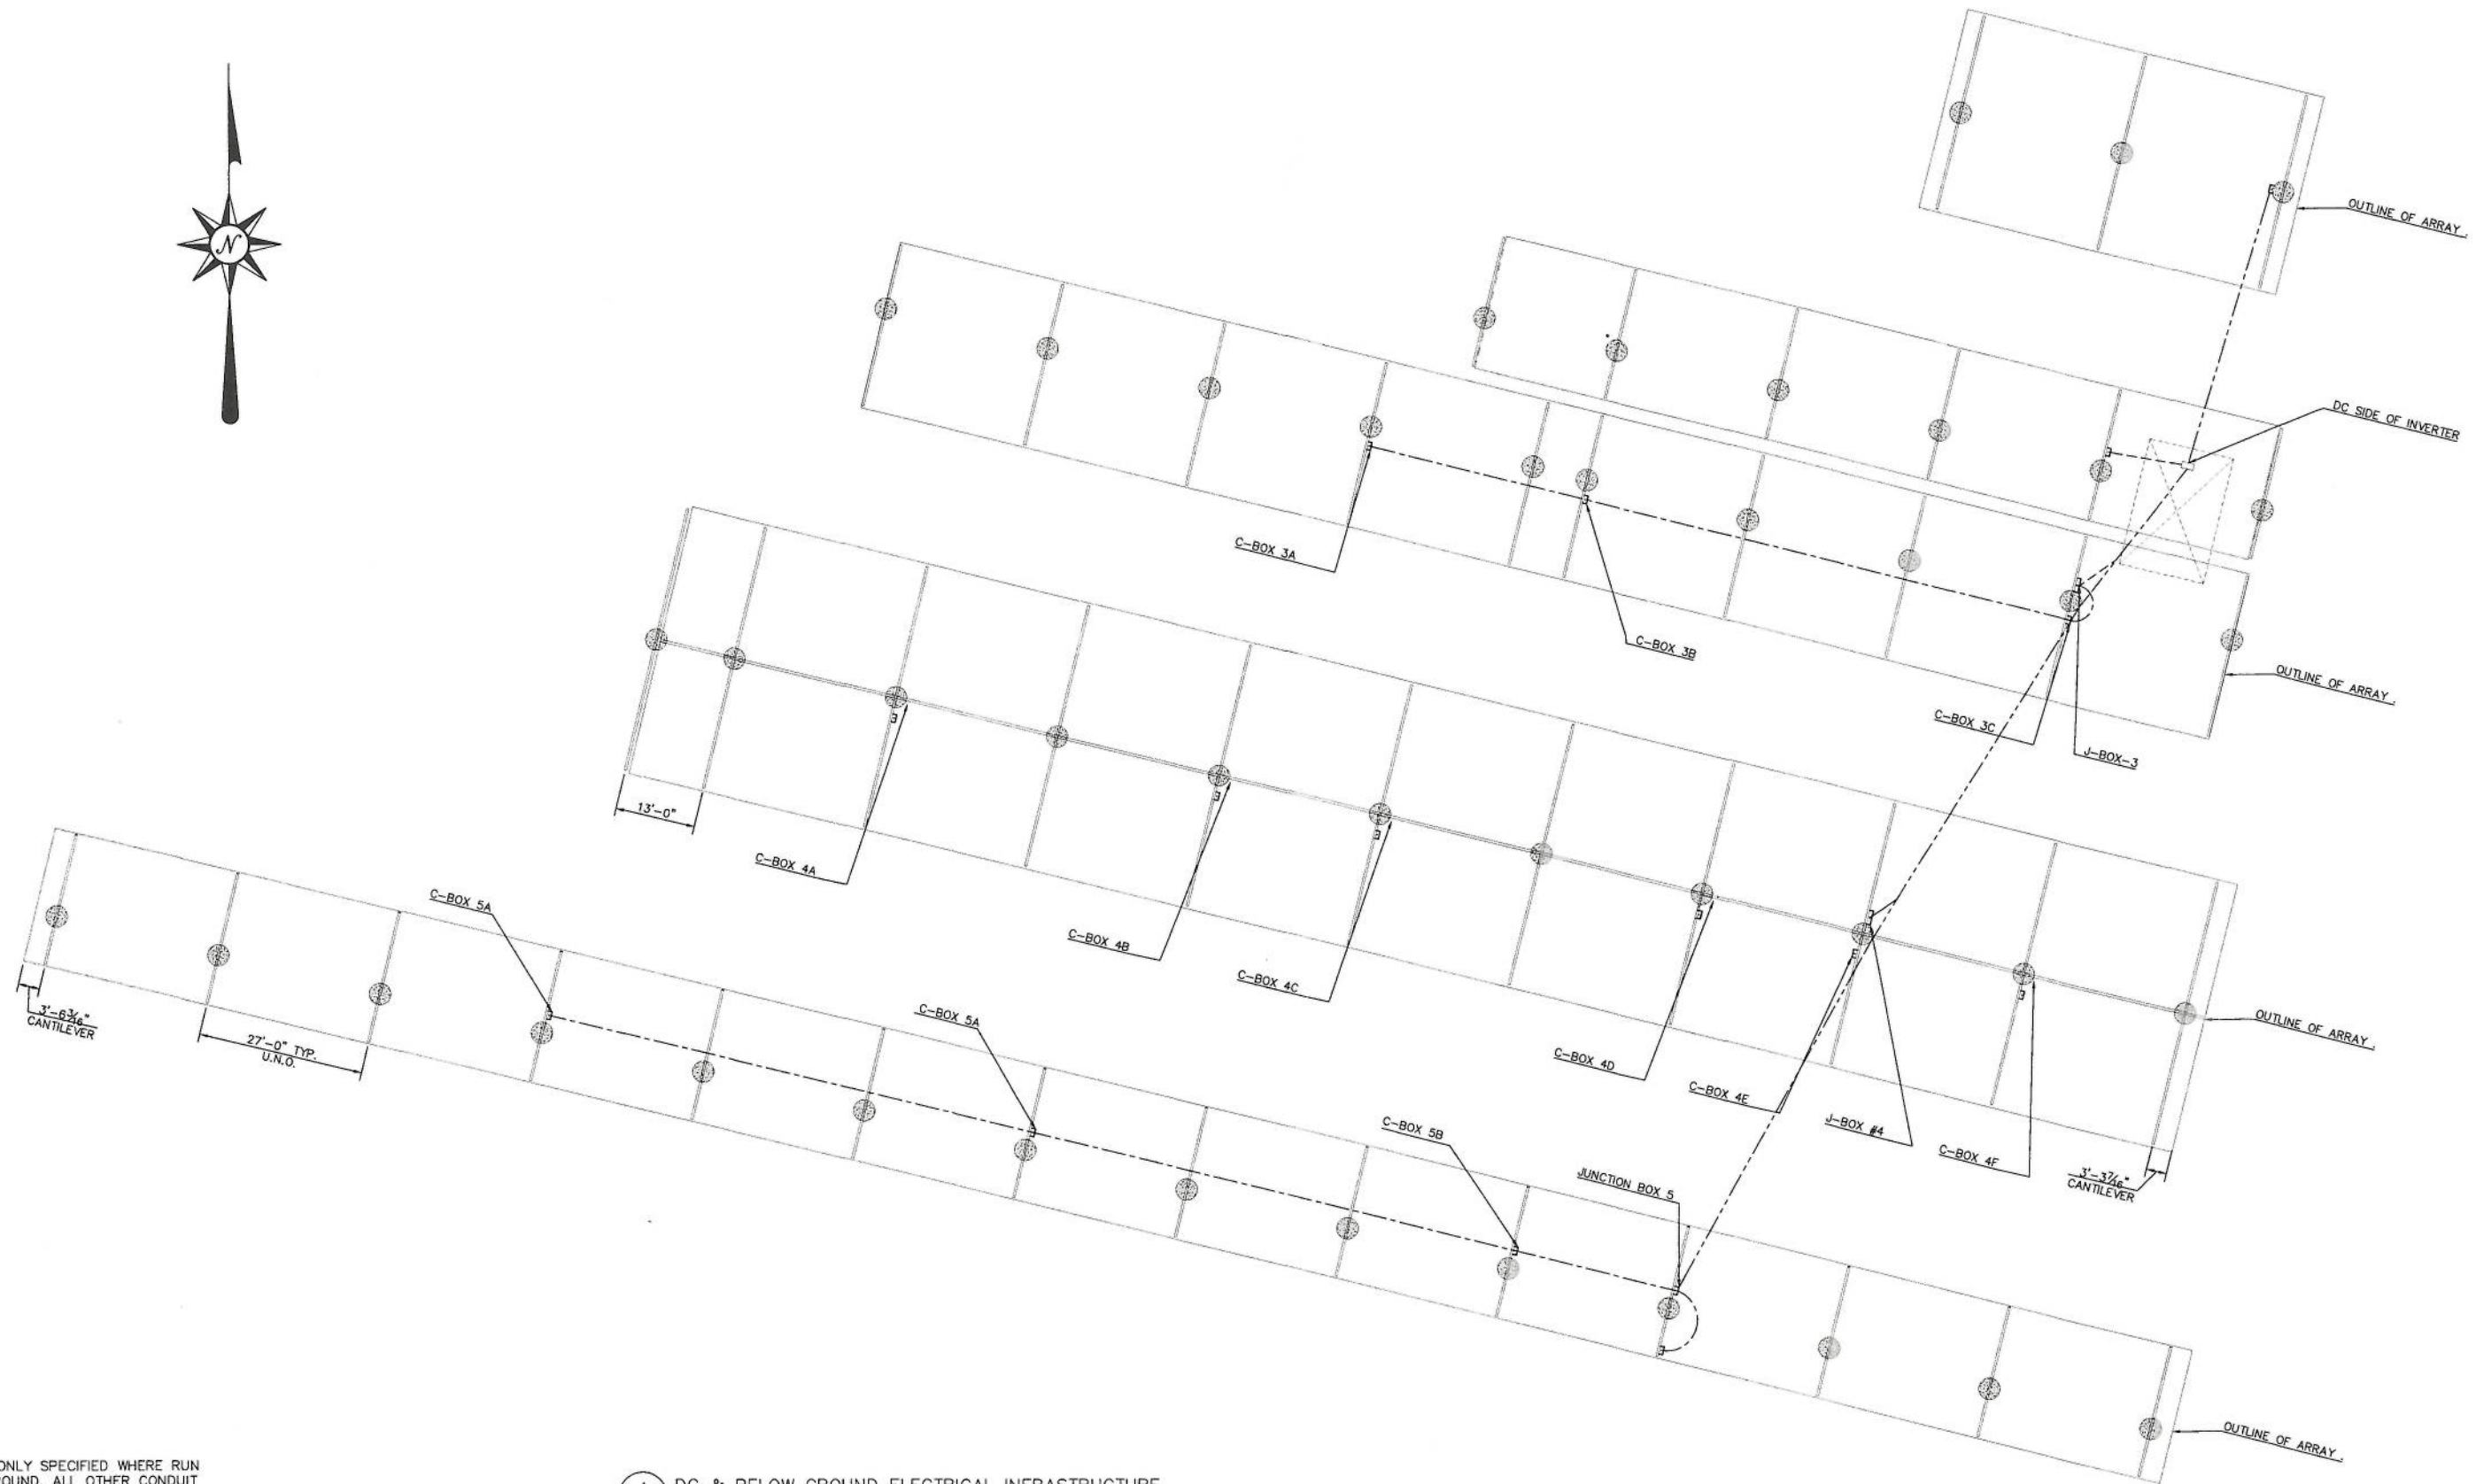

NOTE:
CONDUIT ONLY SPECIFIED WHERE RUN
BELOW GROUND. ALL OTHER CONDUIT
TO BE SPECIFIED BY MEC ELECTRICAL
INC.

A DC & BELOW GROUND ELECTRICAL INFRASTRUCTURE
0.1 SCALE: 1"=150'



MOUNTAIN VIEW SOLAR & WIND
11500 Valley Rd. Berkeley Springs, WV 25411
ph. 304.258.4733 postmaster@mtvsolar.com

APUS Finance Center Buchanan & 2nd
St. Charlestown, WV 25313

REVISIONS				DC & BELOW GROUND ELECTRICAL INFRASTRUCTURE			
No.	By	Date	DESCRIPTION	THE DRAWINGS AND DATA IN THIS DOCUMENT, AND THE INTELLECTUAL PROPERTY AND CONFIDENTIAL INFORMATION IT CONTAINS ARE THE PROPERTY OF MOUNTAIN VIEW SOLAR AND WIND. ANY PARTY ACCEPTING THIS DOCUMENT DOES SO IN CONFIDENCE AND AGREES THAT IT SHALL NOT BE DUPLICATED, IN WHOLE OR IN PART, NOR DISCLOSED TO OTHERS WITHOUT THE WRITTEN CONSENT.			
1.	TEY/CH	10/24/2011	ELECTRICAL LAYOUT	SCALE	DATE	DRAWN BY	DESCRIPTION
2.	TEY/CH	12/10/2011	ESDP GRID	1"=150'	DATE	TEY/CH	AS-BUILT
3.	TEY/CH	01/12/2013	FINAL				PROJECT NO.
4.							APUS
D-SIZE BORDER: 36" x 24"							SHEET NO.
							A1.02



A ARRAY EQUIP GRND / LAYOUT
0.1 SCALE: 1"=150'



MOUNTAIN VIEW SOLAR & WIND
11500 Valley Rd. Berkeley Springs, WV 25411
ph. 304.258.4733 postmaster@mtvsolar.com

APUS Finance Center Buchanan & 2nd
St. Charlestown, WV 25313

REVISIONS			
No.	By	Date	DESCRIPTION
1.	TEY/CH	10/24/2011	ELECTRICAL LAYOUT
2.	TEY/CH	12/10/2011	EQUIP GRND
3.	TEY/CH	01/12/2013	FINAL
4.			

ARRAY EQUIPMENT GROUND LAYOUT			
THE DRAWINGS AND DATA IN THIS DOCUMENT, AND THE INTELLECTUAL PROPERTY AND CONFIDENTIAL INFORMATION IT CONTAINS ARE THE PROPERTY OF MOUNTAIN VIEW SOLAR AND WIND. ANY PARTY ACCEPTING THIS DOCUMENT DOES SO IN CONFIDENCE AND AGREES THAT IT SHALL NOT BE DUPLICATED, IN WHOLE OR IN PART, NOR DISCLOSED TO OTHERS WITHOUT THE WRITTEN CONSENT.			
SCALE	DATE	DRAWN BY	DESCRIPTION
1"=150'	DATE	TEY/CH	AS-BUILT
PROJECT NO.			APUS
SHEET NO.			A1.03